

NORTHEAST HARBOR VILLAGE CENTER IMPROVEMENTS TOWN OF MOUNT DESERT, MAINE



PROJECT LOCATION



LOCATION MAP: USGS QUADRANGLE: SOUTHWEST HARBOR
MAPTECH® USGS TOPOGRAPHIC SERIES™
SCALE: 1"=500'
©MAPTECH®, INC. 978-933-3000
WWW.MAPTECH.COM/TOPO

SITE LOCATION

INDEX OF DRAWINGS

CIVIL BY: CES, INC.

- C101 OVERALL SITE PLAN AND GENERAL NOTES
- C102 PARTIAL PLAN AND PROFILE - STA 0+00 TO 6+00
- C103 PARTIAL PLAN AND PROFILE - STA 6+00 TO 11+75
- C104 PROPOSED CURBING AND PAVEMENT MARKINGS PLAN
- C105 STORM DRAINAGE IMPROVEMENTS - STA 0+00 TO 6+00
- C106 STORM DRAINAGE IMPROVEMENTS - STA 6+00 TO 11+75

- C501 SITE DETAILS
- C502 SITE DETAILS

LANDSCAPE BY: RICHARDSON & ASSOCIATES, LANDSCAPE ARCHITECTS

- L-0.0 KEY PLAN
- L-1.1 MATERIALS & LAYOUT - POP-UP PARK
- L-1.2 MATERIALS & LAYOUT - BANK
- L-1.3 MATERIALS & LAYOUT - HARBORSIDE ROAD

- L-2.0 PLANTING PLAN - OVERALL STREET TREES; PLANTING DETAILS
- L-2.1 PLANTING PLAN

- L-3.0 DETAILS - HARDSCAPE
- L-3.1 DETAILS - HARDSCAPE
- L-3.2 DETAILS - HARDSCAPE

ELECTRICAL BY: CES, INC.

- E-001 SYMBOLS, ABBREVIATIONS, NOTES AND DETAILS
- E-002 ELECTRICAL DETAILS

- E-101 ELECTRICAL PART PLAN A
- E-102 ELECTRICAL PART PLAN B
- E-103 ELECTRICAL PART PLAN C
- E-104 ELECTRICAL PART PLAN D
- E-105 ELECTRICAL PART PLAN E

WATER SYSTEM BY: WOODARD & CURRAN


- W-101 PARTIAL PLAN - WATER SYSTEM UPGRADE STA 0+00 TO STA 6+00
- W-102 PARTIAL PLAN - WATER SYSTEM UPGRADE STA 6+00 TO STA 11+75


- W-103 STANDARD DETAILS 1
- W-104 STANDARD DETAILS 2



465 So. Main Street, P.O. Box 639, Brewer, ME 04412 Tel: 207-989-4824 Fax 207-989-4881
1366 State Highway 102, Bar Harbor, ME 04609 Tel: 207-288-0587 Fax 207-288-0588
61 Dublin Street, P.O. Box 587, Machias, ME 04654 Tel: 207-255-3270 Fax 207-255-8367
549 Main Street, P.O. Box 827, Presque Isle, ME 04769 Tel: 207-764-8412 Fax: 207-764-8414
44 Main Street, Suite 204, Waterville, ME 04903 Tel: 207-680-2202 Fax: 207-680-2204
640 Main Street, Lewiston, ME 04240 Tel: 207-795-6009 Fax: 207-795-6128

ISSUED FOR CONSTRUCTION
MARCH 26, 2019

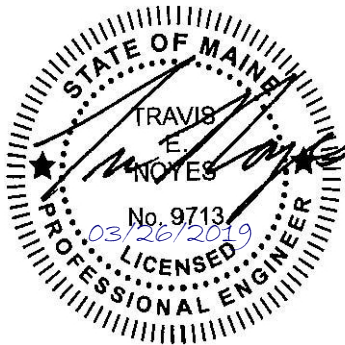

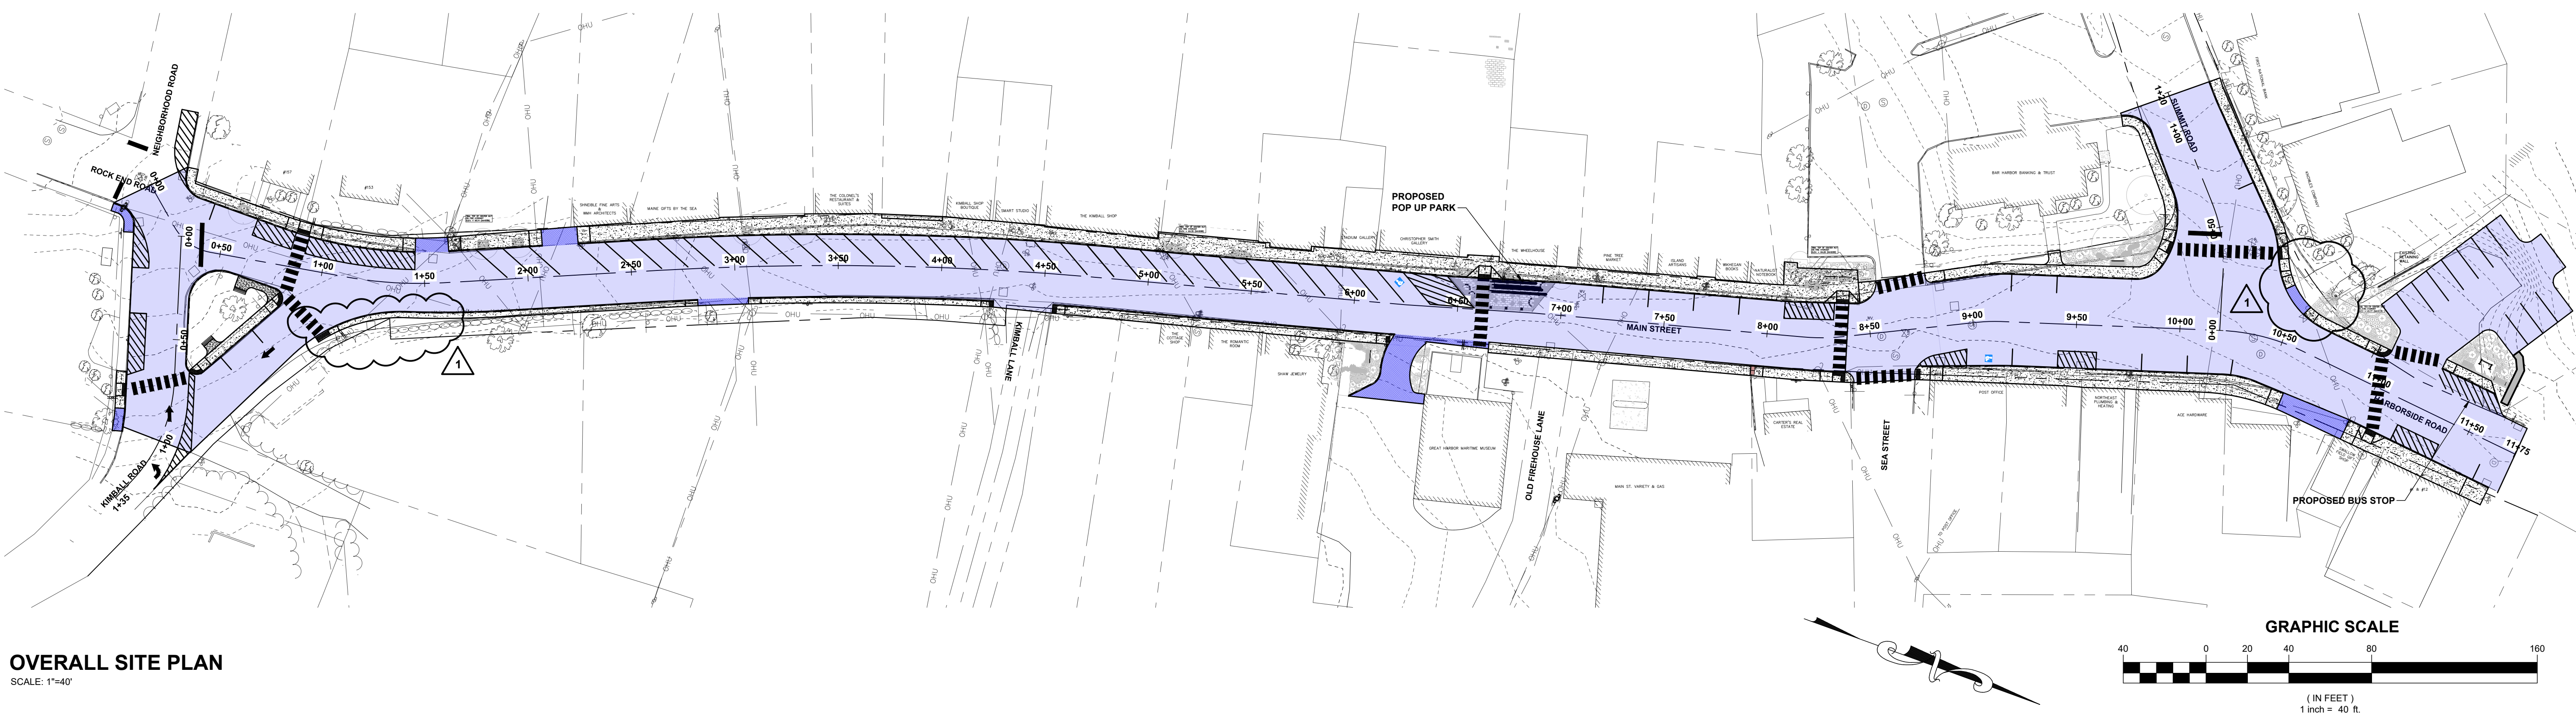

GENERAL NOTES


EROSION CONTROL NOTES

1. THIS PLAN DEPICTS EXISTING CONDITIONS AS FOUND AND SURVEYED BY CES, INC. IN JULY AND AUGUST OF 2017.
2. PROPERTY LINES SHOWN WERE OBTAINED FROM THE STATE OF MAINE GIS DATA CATALOG.
3. THE DIRECTION OF LINES AND UNDERLYING COORDINATE SYSTEM IS BASED UPON THE MAINE STATE PLANE COORDINATE SYSTEM, EAST ZONE, US FOOT, NAD 83 DATUM.
4. ELEVATIONS REFER TO THE NORTH AMERICAN VERTICAL DATUM OF 1988 (NAVD 88).


1. PLAN ENTITLED: "MAINE STATE HIGHWAY COMMISSION RIGHT OF WAY MAP, STATE AID HIGHWAY NO. 4, MOUNT DESERT, HANCOCK COUNTY, MAINE STATE PROJECT NO. 257(501), DATED JANUARY 1956.
2. PARTIAL SITE PLAN OF MAIN STREET STORMDRAIN SURVEY.

LEGEND:

ABBREVIATIONS

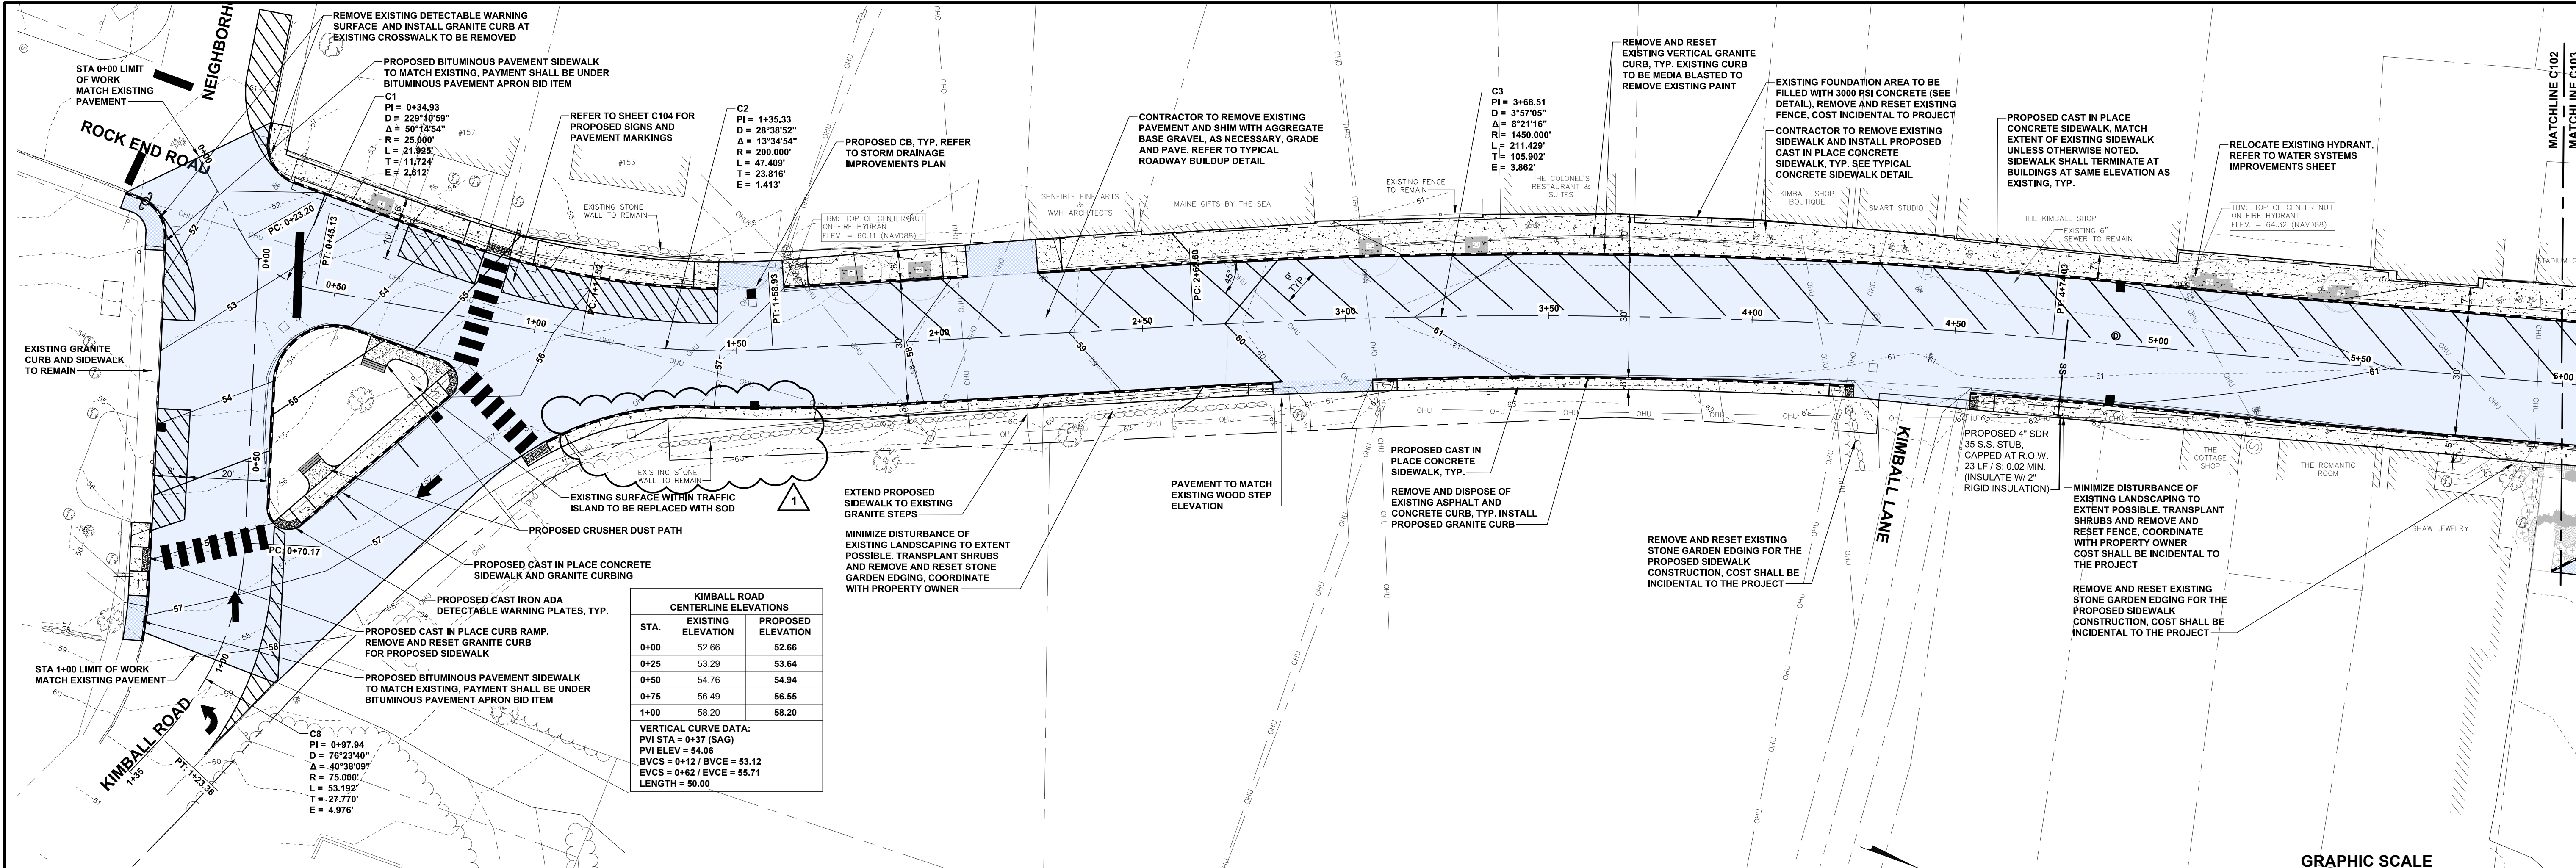

PARTIAL SITE PLAN STA 0+00 TO 6+00
SCALE: 1"=20'

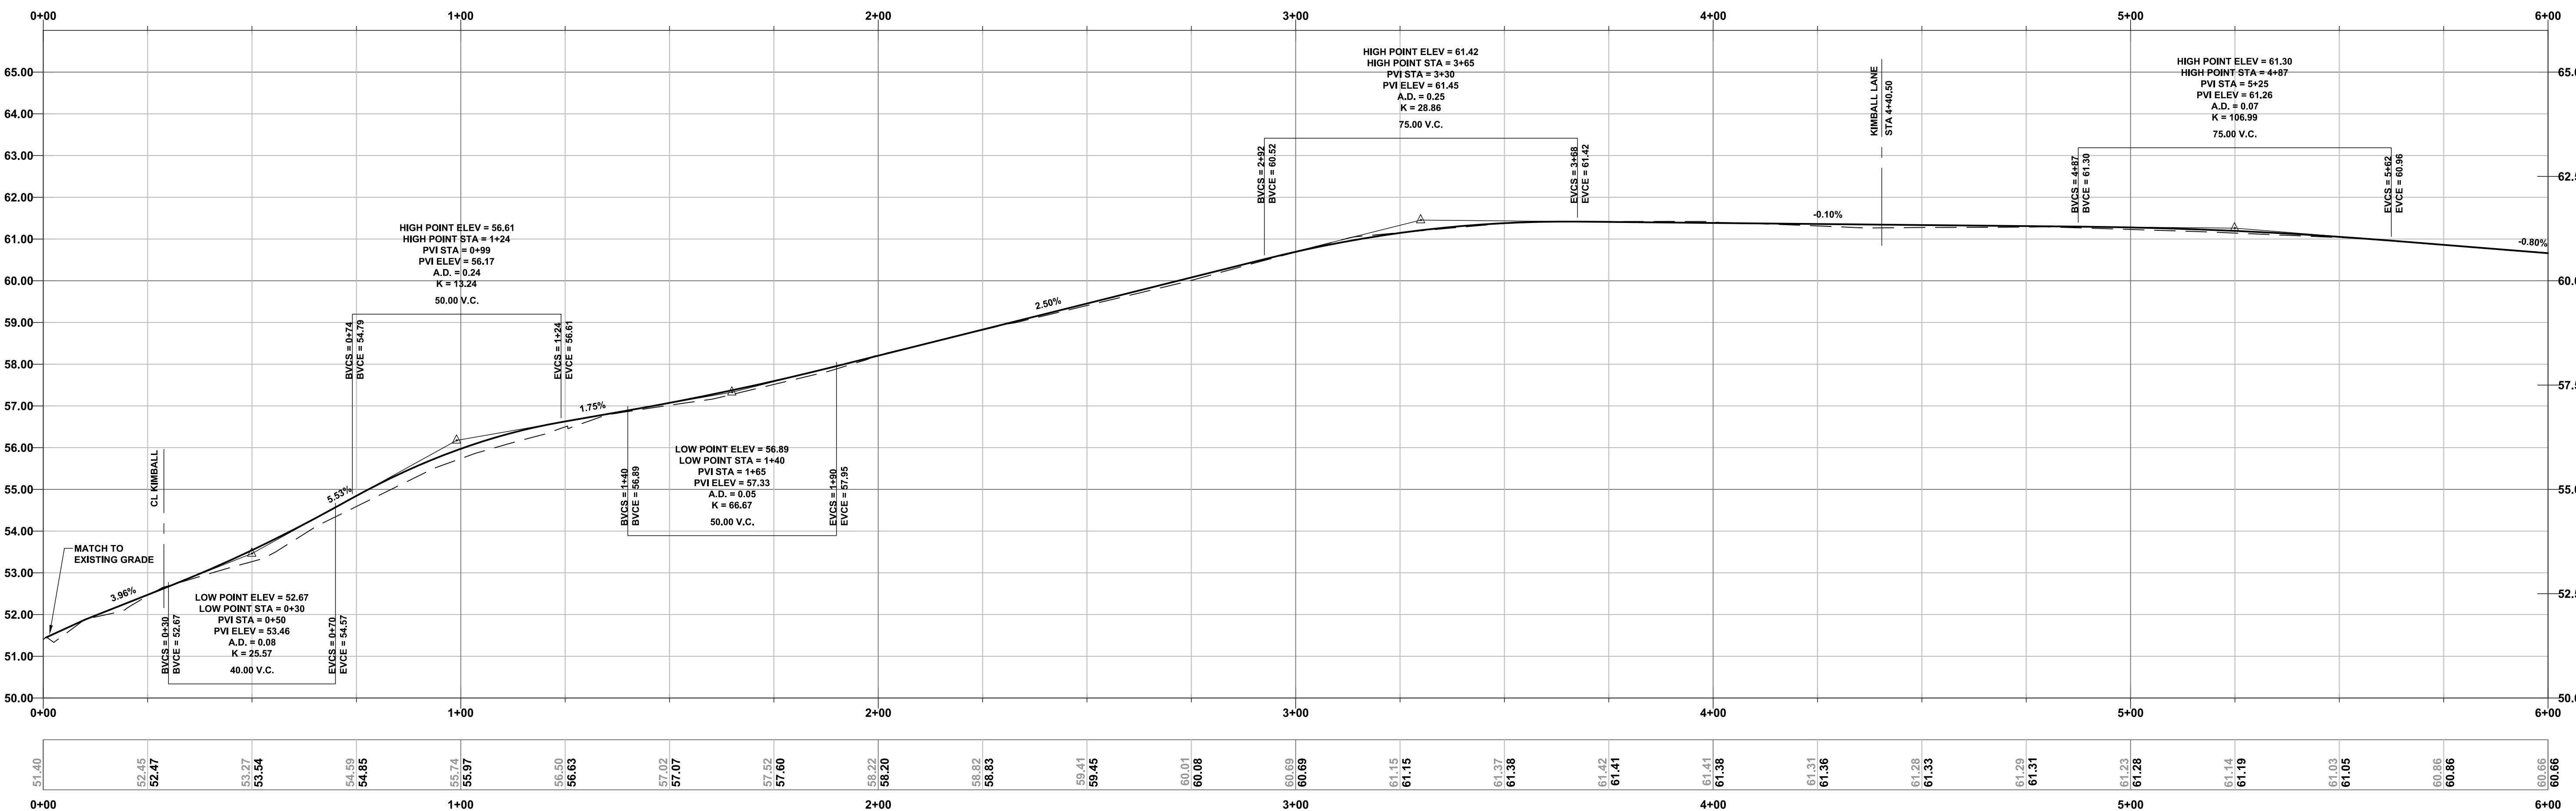

PROFILE VIEW - MAIN STREET - STA 0+00 TO 6+00
SCALE: H: 1"=20' / V: 1"=2'

CES INC
Engineers • Environmental Scientists • Surveyors

NORTHEAST HARBOR VILLAGE CENTER IMPROVEMENTS
TOWN OF MOUNT DESERT, MAINE


MAIN STREET PARTIAL PLAN AND PROFILE
STA 0+00 TO 6+00

NO.	REV.	DATE	BY	CHKD.	DESCRIPTION
1	0				



ISSUED FOR CONSTRUCTION

STATE OF MAINE
Professional Engineer
No. 9713
Travis M. Motes

SCALE: 1"=20'
DATE: 2018-12-17
DRAWN BY: BLO / CHECKED BY: NAG
DESIGNED BY: BLO / APPROVED BY: TEN
JOB NUMBER: 10328.016
DRAWING NUMBER: C102

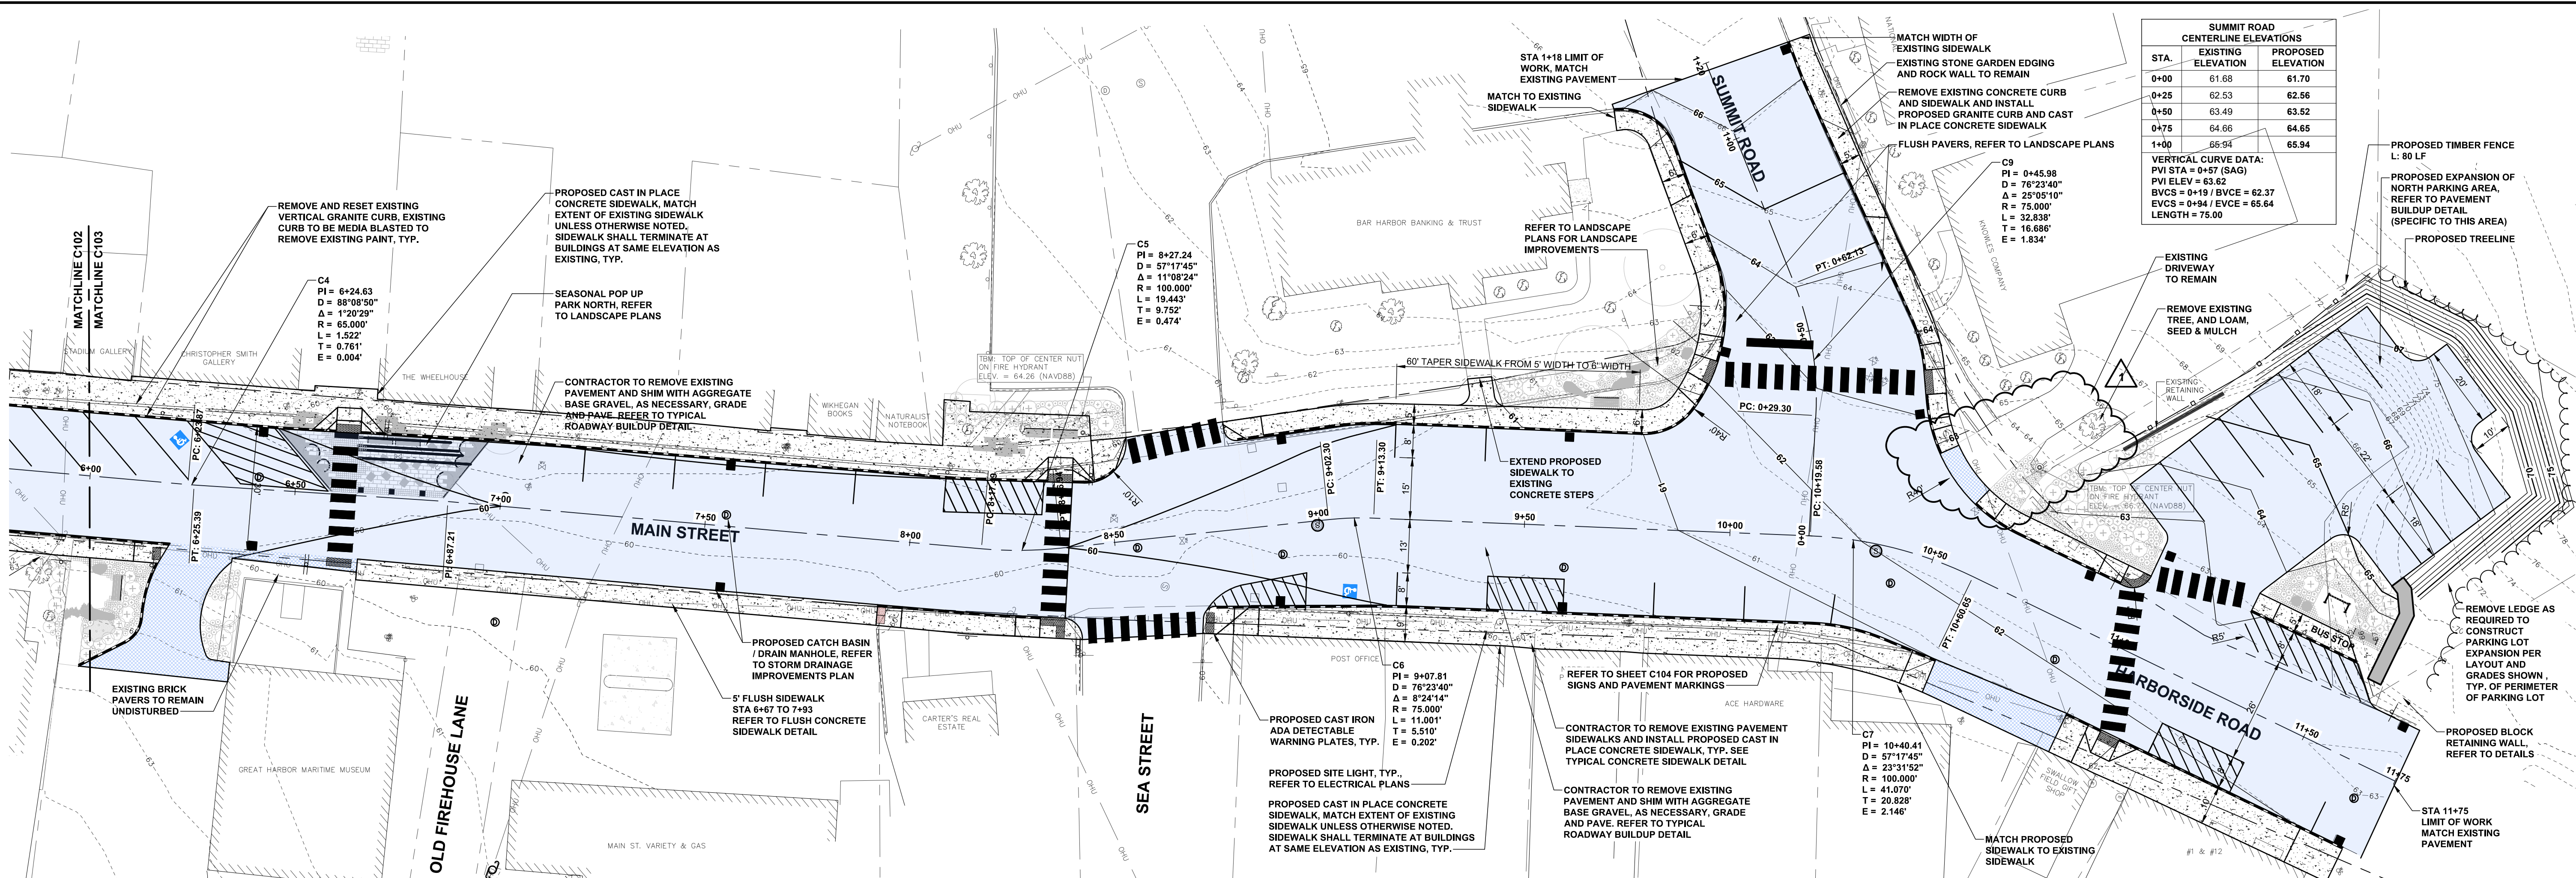

PARTIAL SITE PLAN STA 6+00 TO 11+75
SCALE: 1"=20'

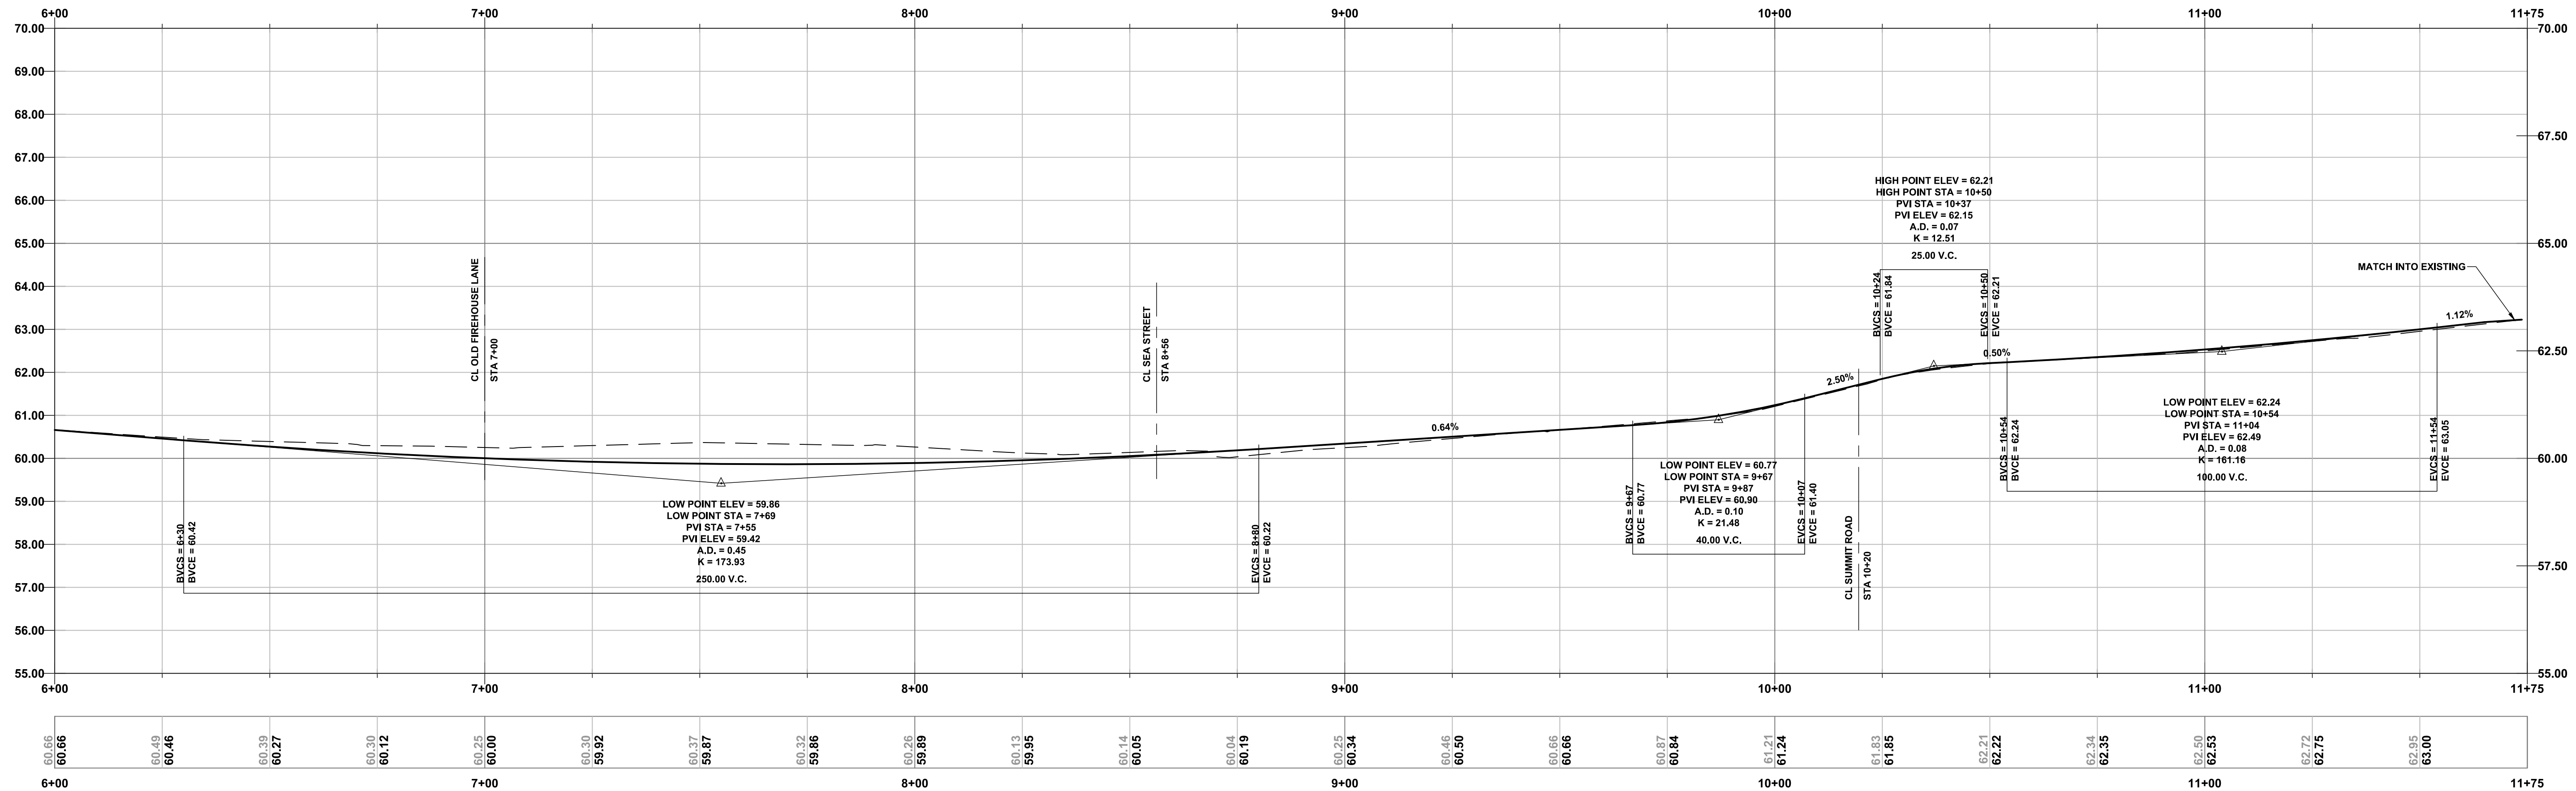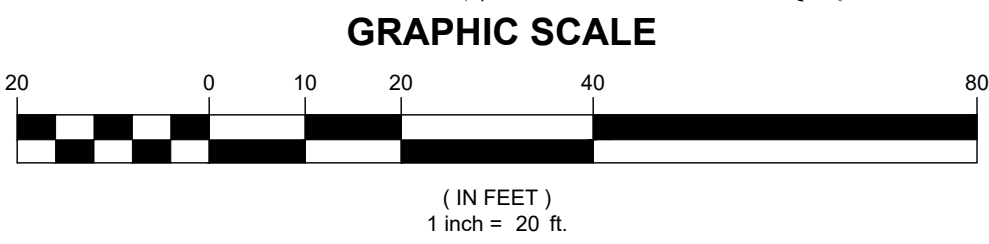

PROFILE VIEW - MAIN STREET - STA 6+00 TO 11+75
SCALE: H: 1"=20' / V: 1"=2'

CES INC
Engineers • Environmental Scientists • Surveyors

NORTHEAST HARBOR VILLAGE CENTER IMPROVEMENTS
TOWN OF MOUNT DESERT, MAINE

MAIN STREET PARTIAL PLAN AND PROFILE
STA 6+00 TO 11+75

NO.	REV.	DATE	DESCRIPTION
1	0		
2	0		
3	0		
100	0		

ISSUED FOR CONSTRUCTION

SCALE: 1"=20'


DATE: 2018-12-17

DRAWN BY: BLO CHECKED BY: NAG


DESIGNED BY: BLO APPROVED BY: TEN

JOB NUMBER: 10328.016


DRAWING NUMBER: C103

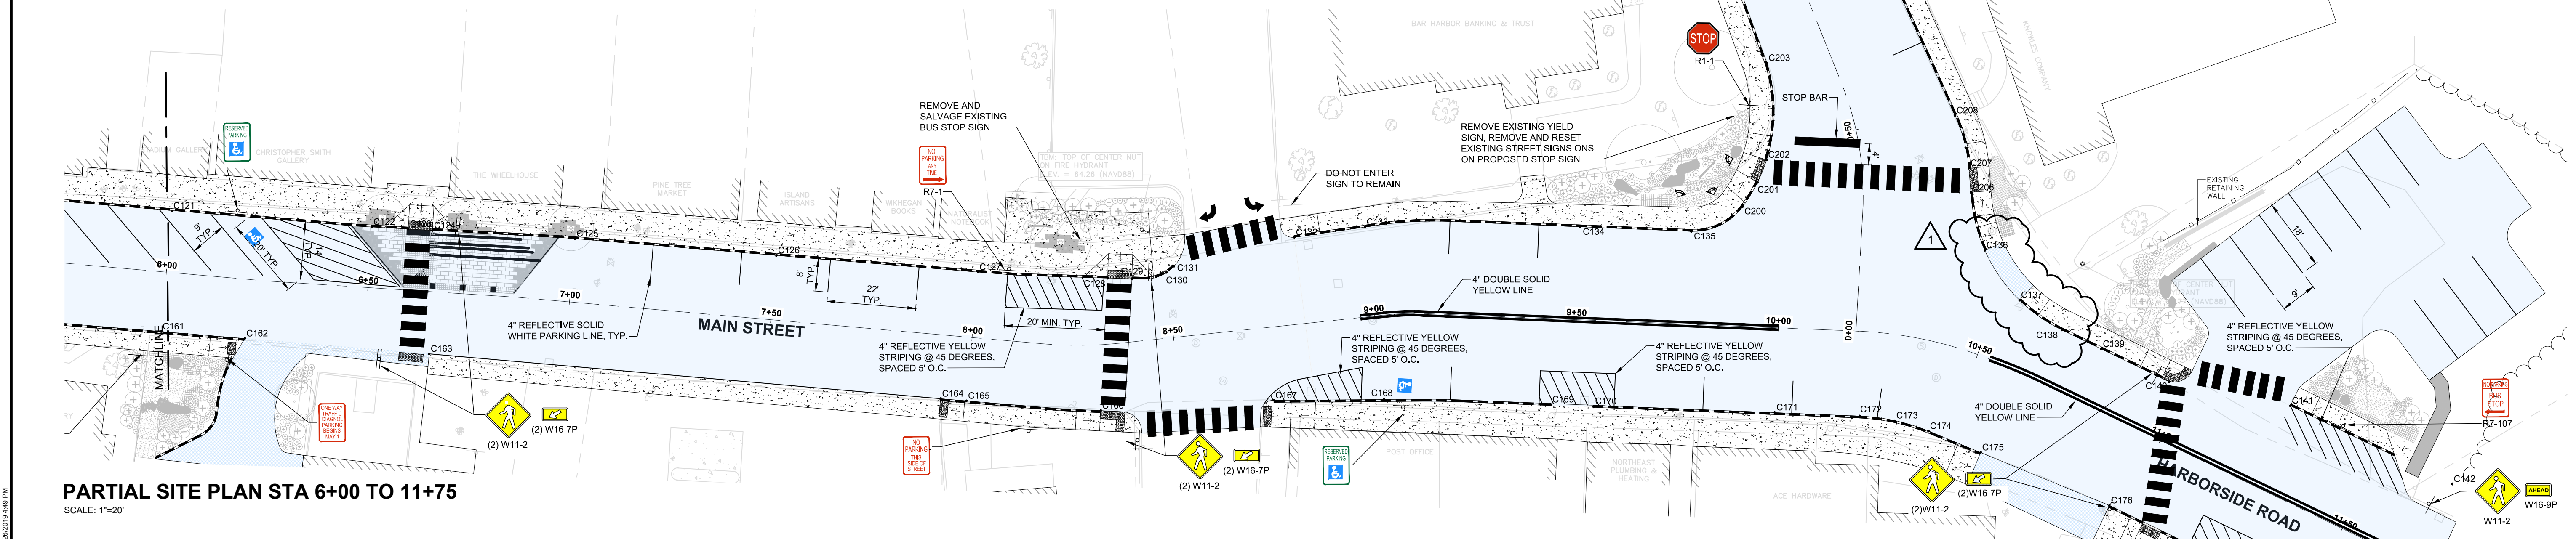

KIMBALL ROAD CURBING GEOMETRICS & OFFSETS TABLE					
POINT	STATION	OFFSET	NORTHING	EASTING	NOTE
300	0+32	48.688 L	228006.8406	1039670.4293	
301	0+65	13.899 L	228004.1215	1039712.3546	
302	0+65	6.653 L	228004.2928	1039714.4937	HC RAMP
303	0+61	5.030 L	228002.6453	1039711.4343	
304	0+31	5.020 L	228021.8638	1039662.4311	
305	0+16	24.382 L	228036.8114	1039662.7445	
306	0+66	22.962 R	228006.4749	1039724.7762	BEGIN
307	0+73	22.954 R	228008.1960	1039730.4558	HC RAMP
308	0+82	22.361 R	228009.9726	1039736.1867	HC RAMP
309	0+97	19.820 R	228012.9676	1039746.6418	
310	+105	17.912 R	228014.2858	1039752.7097	END

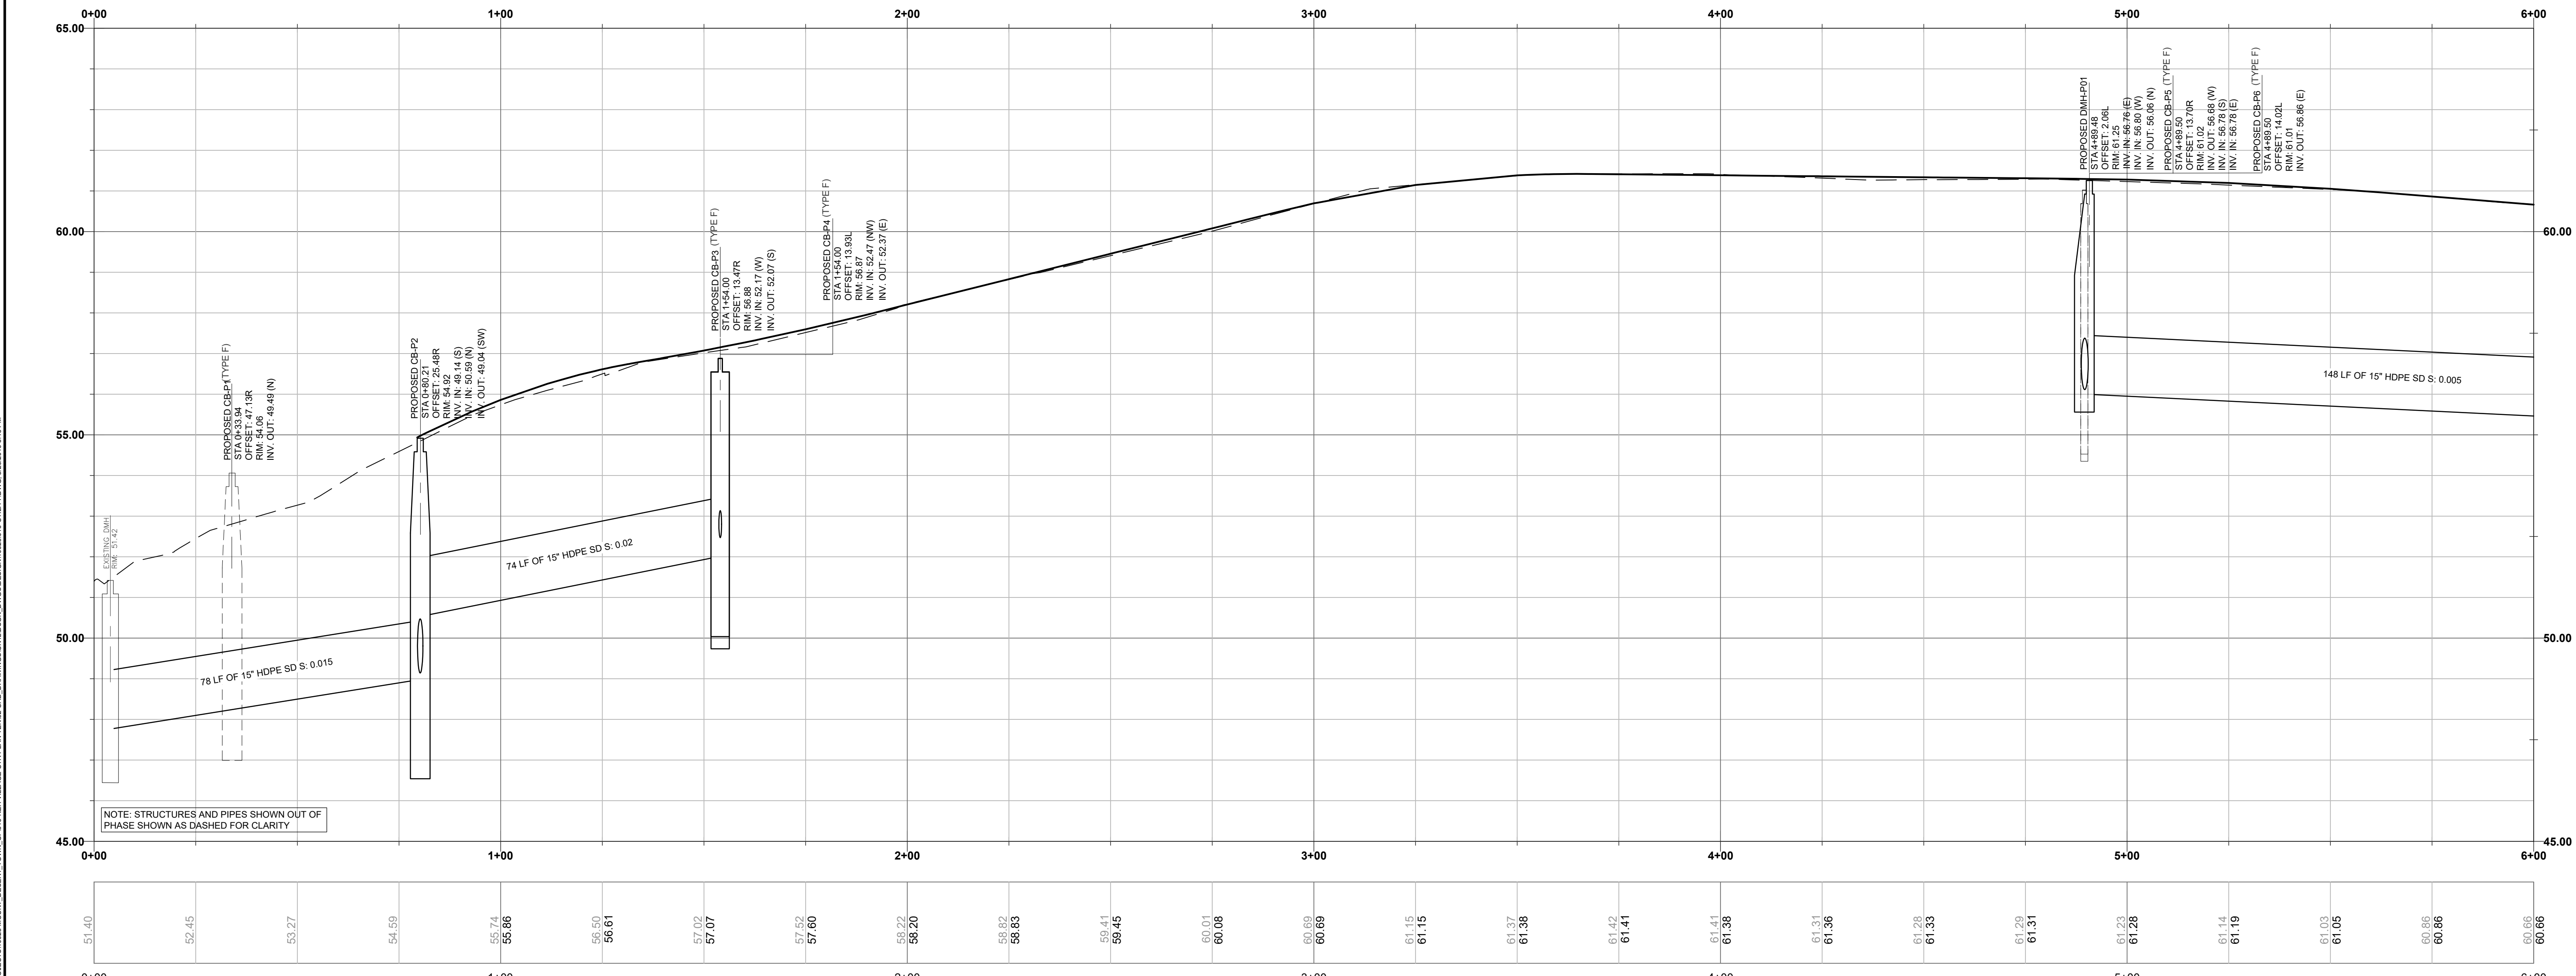

SCALE: 1"=20'

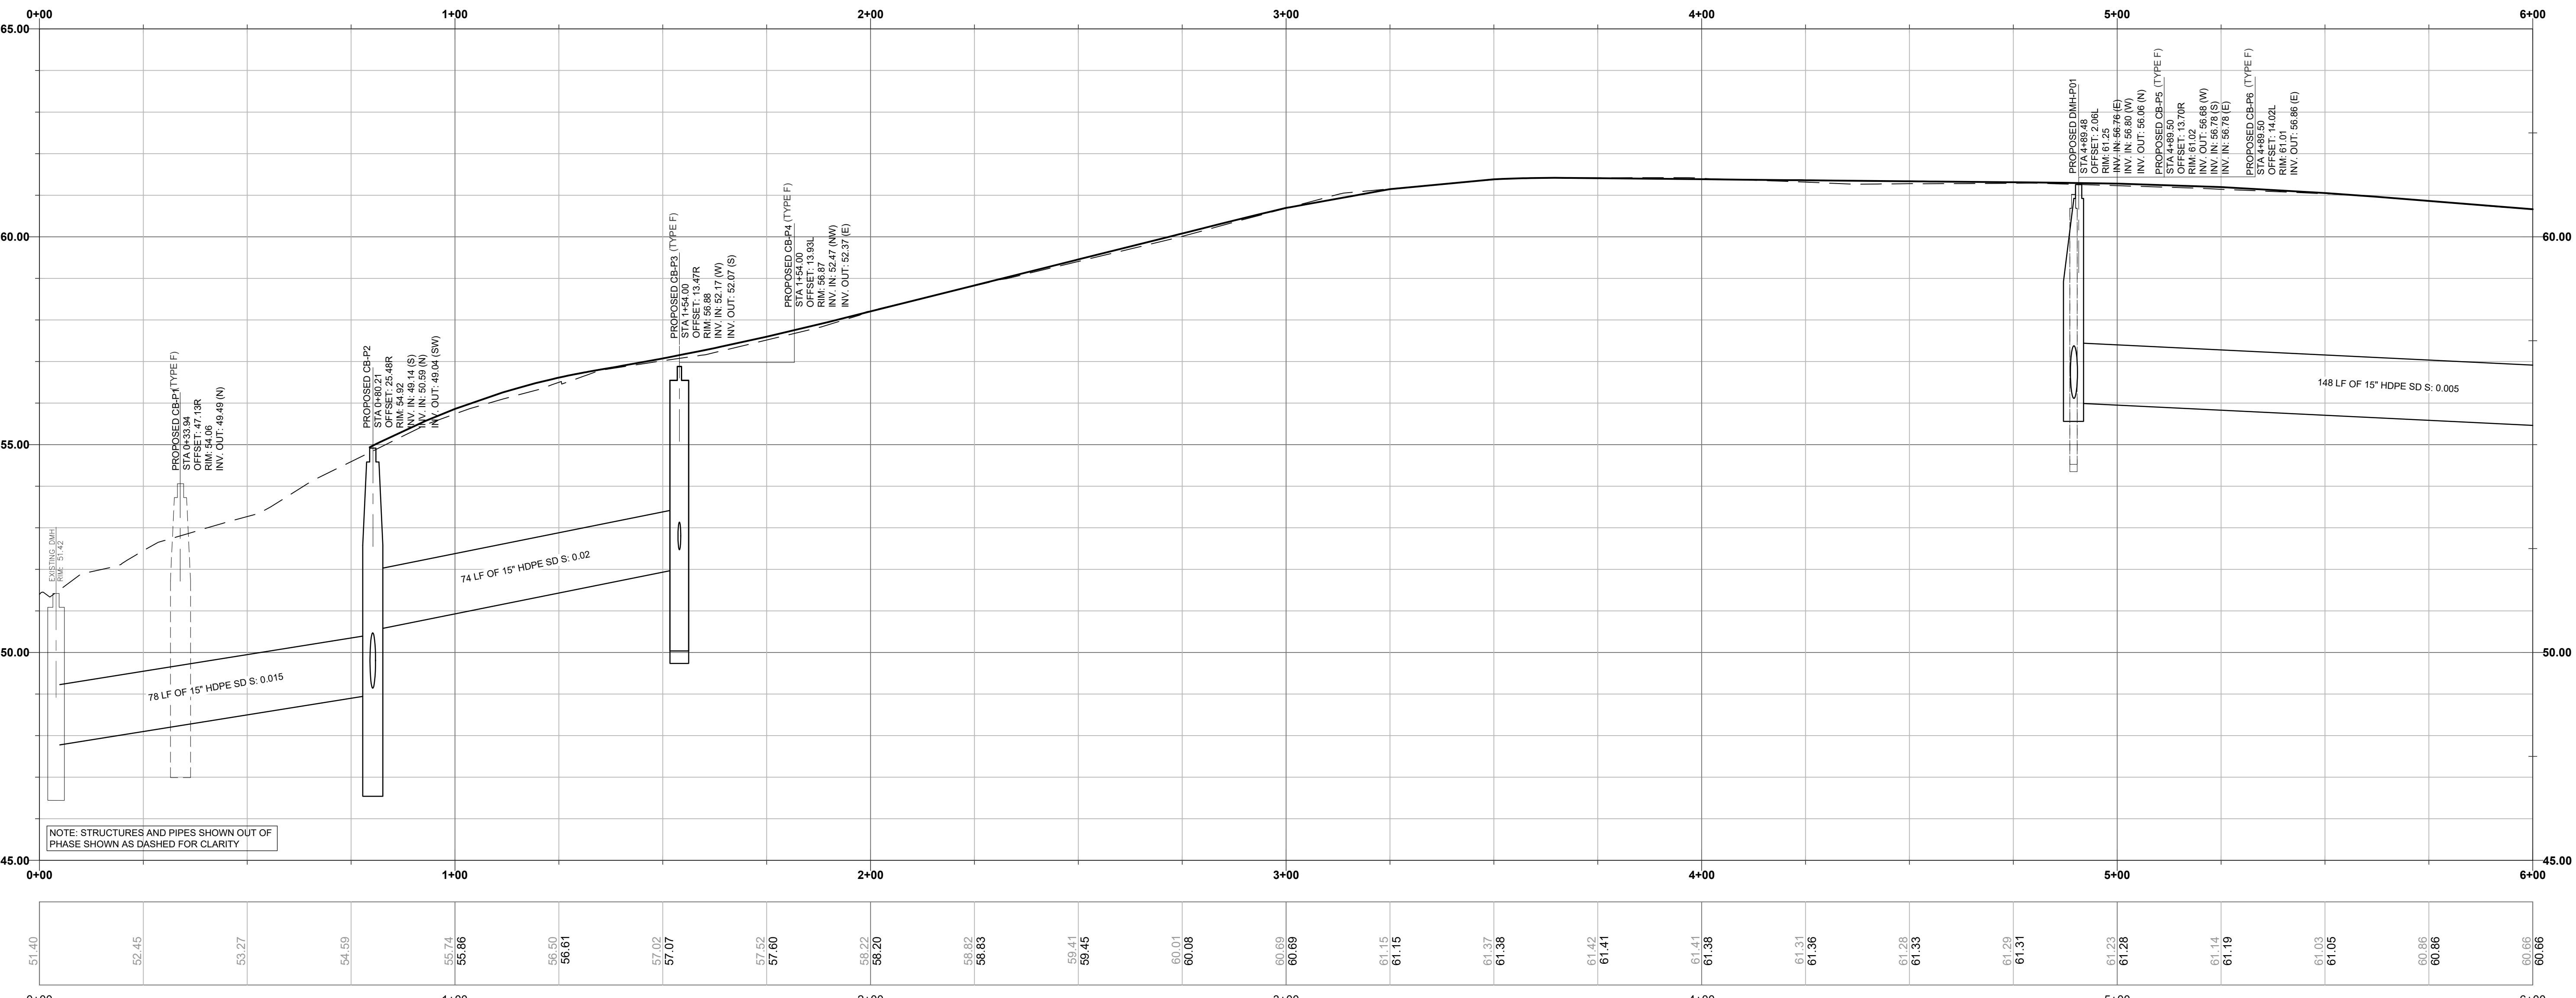

SCALE: H: 1"=20' / V: 1"=2'

 
NORTHEAST HARBOR VILLAGE CENTER IMPROVEMENTS
TOWN OF MOUNT DESERT, MAINE

PROJECT TITLE

MAIN STREET PARTIAL PLAN
STORM DRAINAGE IMPROVEMENTS
STA 0+00 TO 6+00

SHEET#

ISSUED FOR CONSTRUCTION



STORM DRAIN SERVICE EX'S & SERVICE

SCALE 1"=20'

DATE 2018-12-17

DRAWN BY BLQ **CHECKED BY** NAG

DESIGNED BY BLQ **APPROVED BY** TEN

JOB NUMBER 10328.016

DRAWING NUMBER

CONTRACTOR

OWNER

DATE

PROJECT

STATION

REVISIONS

DATE

DESCRIPTION

PROJECT TITLE

CONTRACTOR

OWNER

DATE

PROJECT

STATION

REVISIONS

DATE

DESCRIPTION

PROJECT TITLE

CONTRACTOR

OWNER

DATE


PROJECT

STATION


REVISIONS

DATE


DESCRIPTION

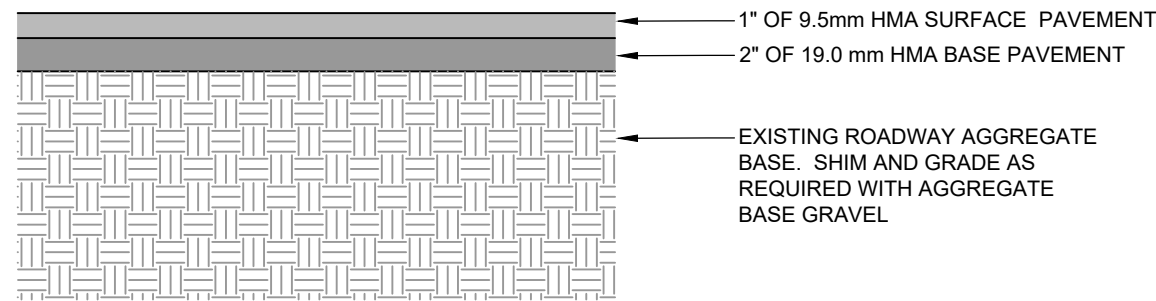

ROADWAY BUILDUP

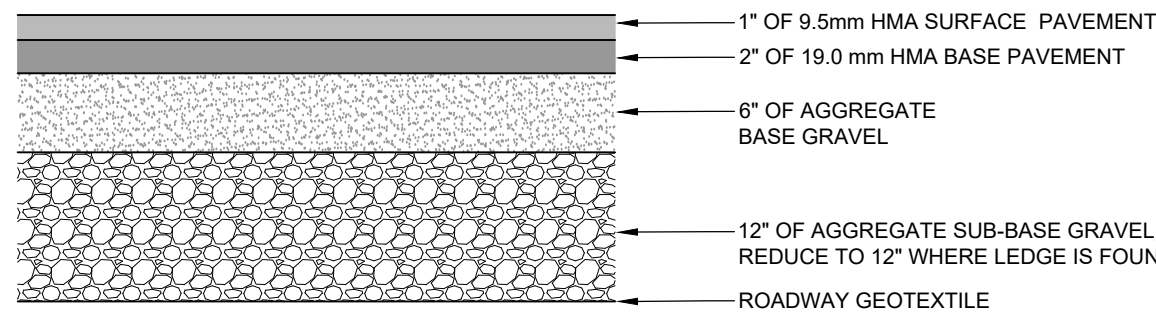


NORTH PARKING AREA

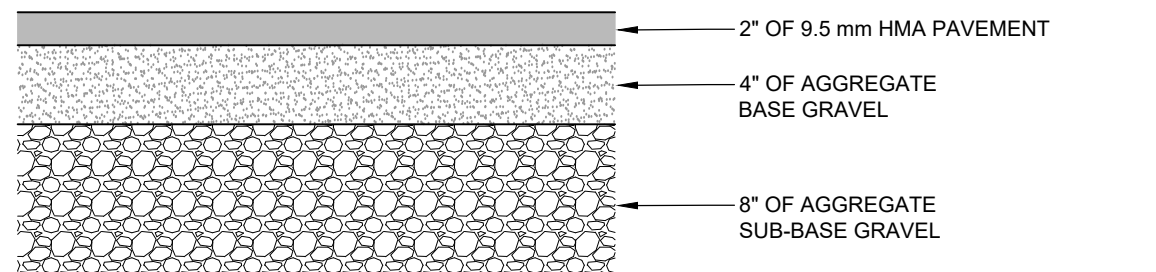


DRIVEWAY APRON

TYPICAL PAVEMENT BUILDUP DETAILS


N.T.S.

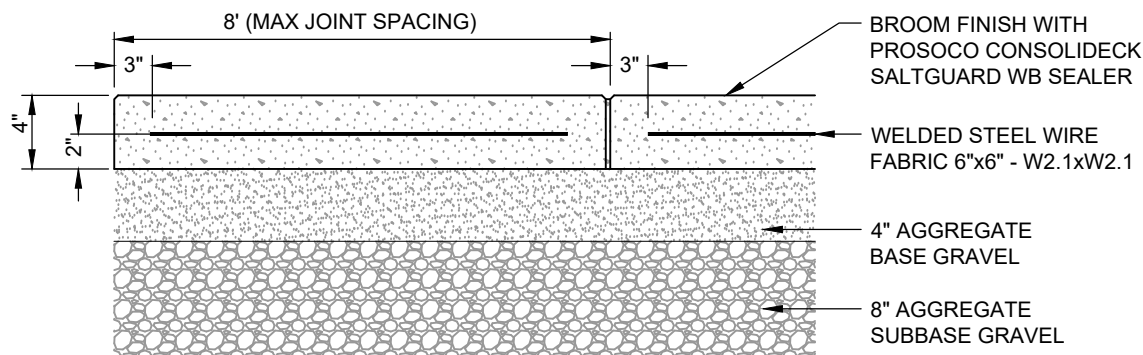

CONCRETE SIDEWALK BUILDUP

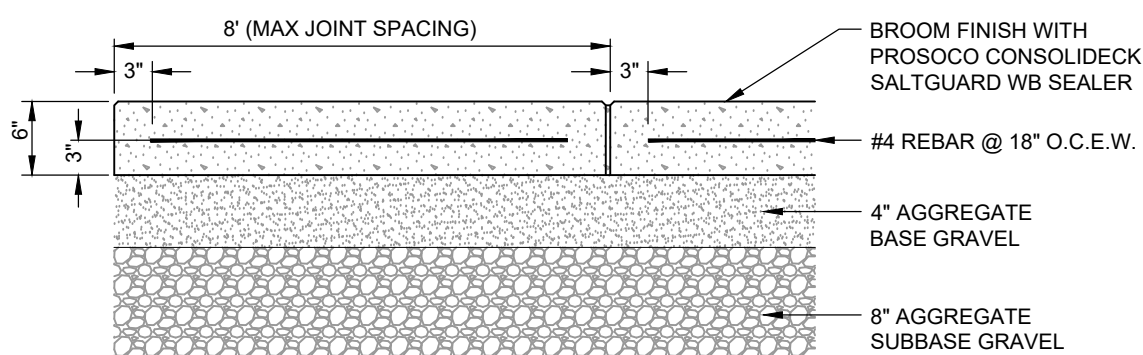


FLUSH CONCRETE SIDEWALK BUILDUP

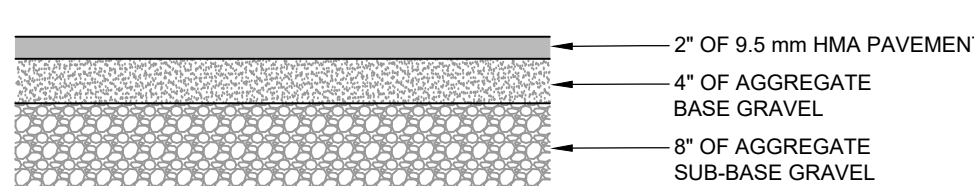

BITUMINOUS SIDEWALK BUILDUP
(BID ALTERNATE)


TYPICAL SIDEWALK BUILDUP DETAIL

N.T.S.

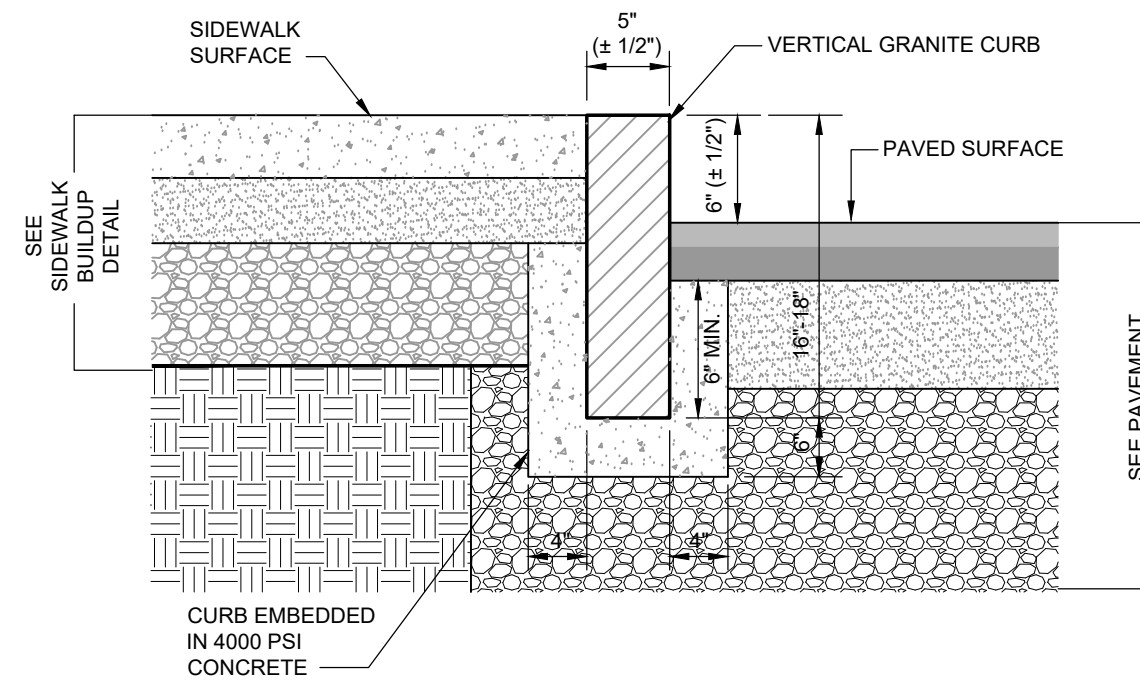


TYPICAL VERTICAL GRANITE CURB DETAIL

N.T.S.

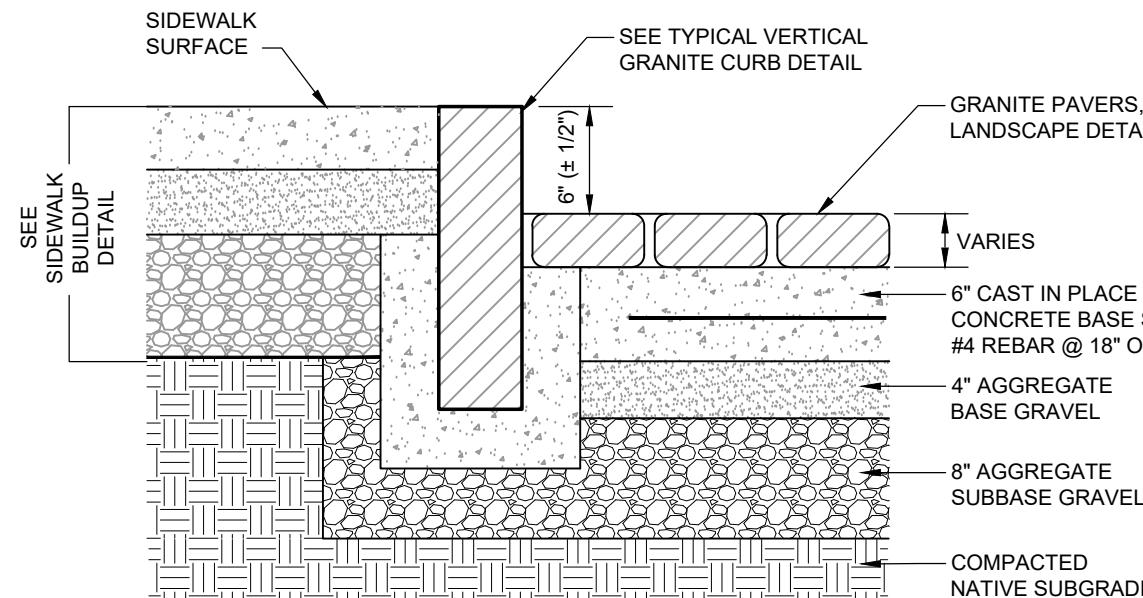


TYPICAL PAVER BASE SLAB BUILDUP DETAIL

N.T.S.

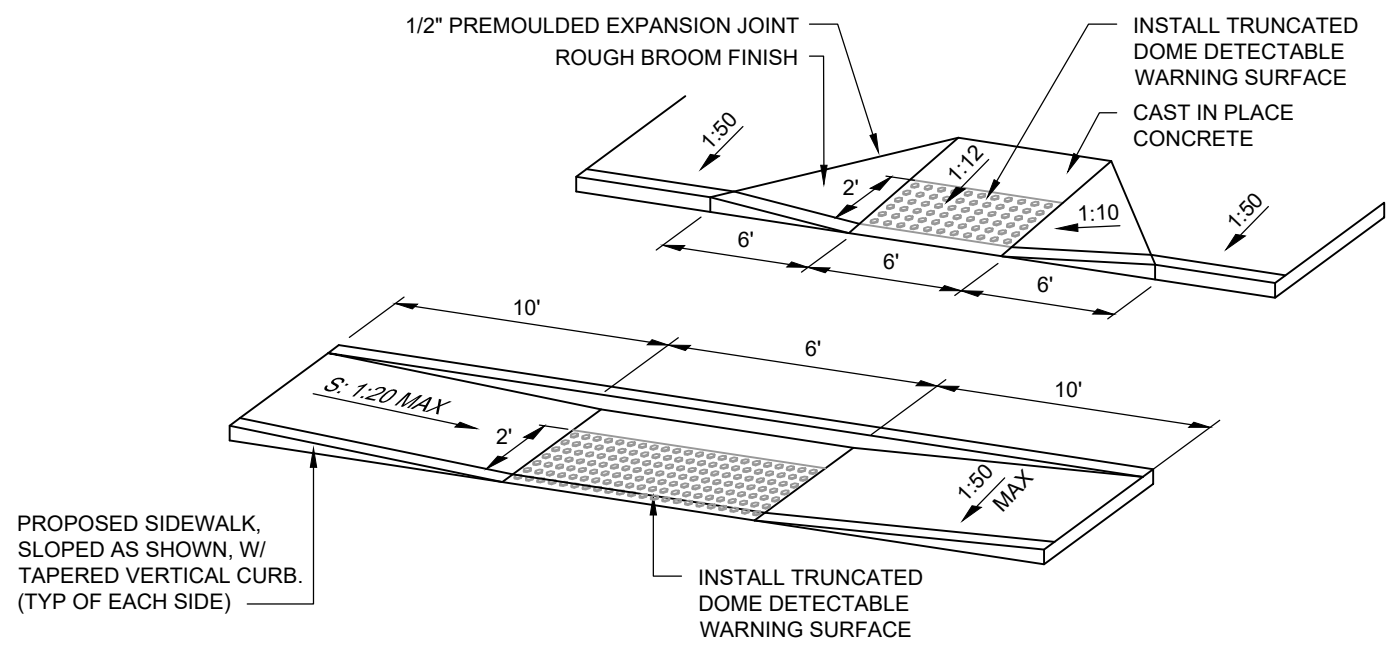


NOTES:

1. THE DETECTABLE WARNING SURFACE SHALL CONSIST OF RAISED TRUNCATED DOMES WITH A DIAMETER OF 0.9 NOMINAL INCHES, A HEIGHT OF 0.2 NOMINAL INCHES, AND A CENTER TO CENTER SPACING OF 2.35 NOMINAL INCHES. THE TEXTURE OF THE WARNING FEATURE MUST CONTRAST WITH THE SURROUNDING SURFACES (EITHER LIGHT ON DARK, OR DARK ON LIGHT).

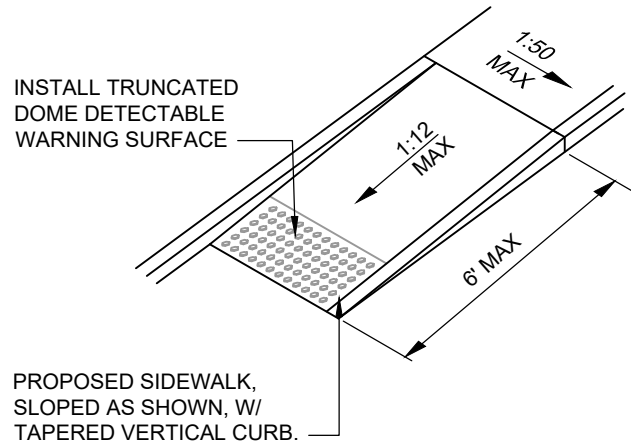


TYPICAL HANDICAP CURB RAMP DETAILS

N.T.S.

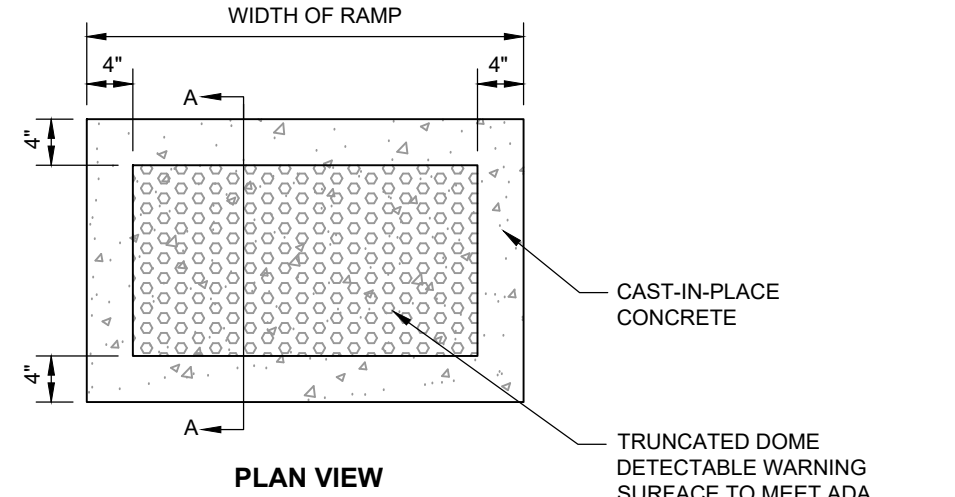

PLAN VIEW

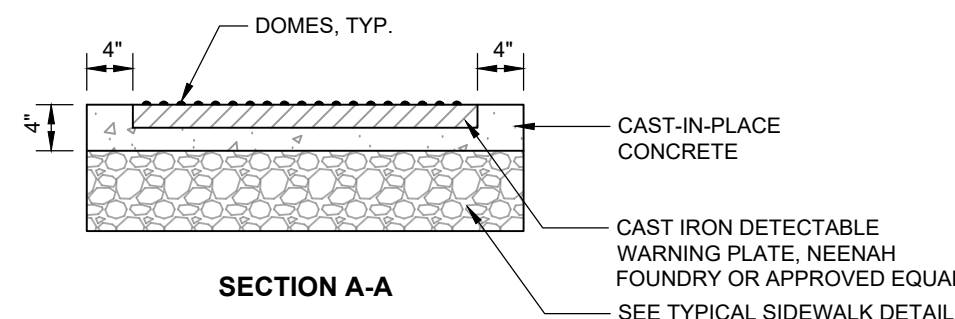


SECTION A-A

NOTES:


1. DETECTABLE WARNINGS SHALL BE AN INTEGRAL PART OF THE RAMP AND COMPLY WITH ALL SECTIONS OF THE ADA ACCESSIBILITY GUIDELINES AND ALL SECTIONS OF THE ADA STANDARDS FOR ACCESSIBLE DESIGN.
2. ALL DETECTABLE WARNING AREAS SHALL START 6'-10" FROM THE FLOW LINE OF THE CURB, BE 24" IN DEPTH AND COVER THE COMPLETE WIDTH OF THE RAMP AREA ONLY.

TYPICAL DETECTABLE WARNING SURFACE DETAIL

N.T.S.

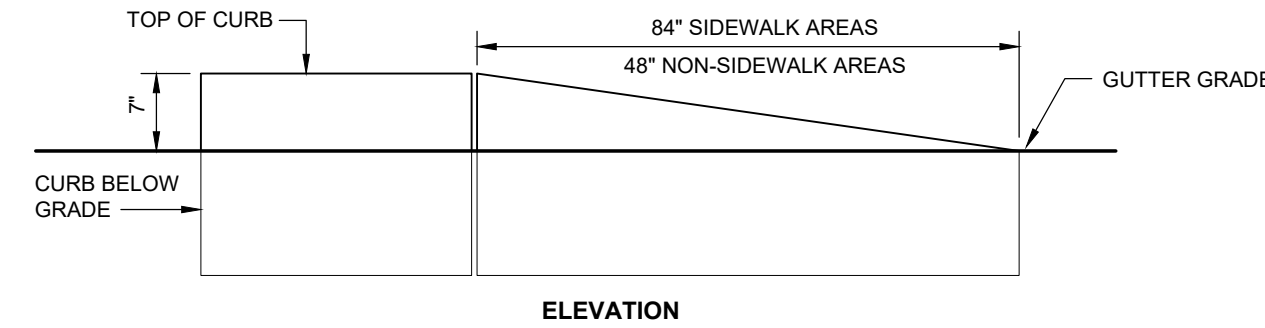


ELEVATION

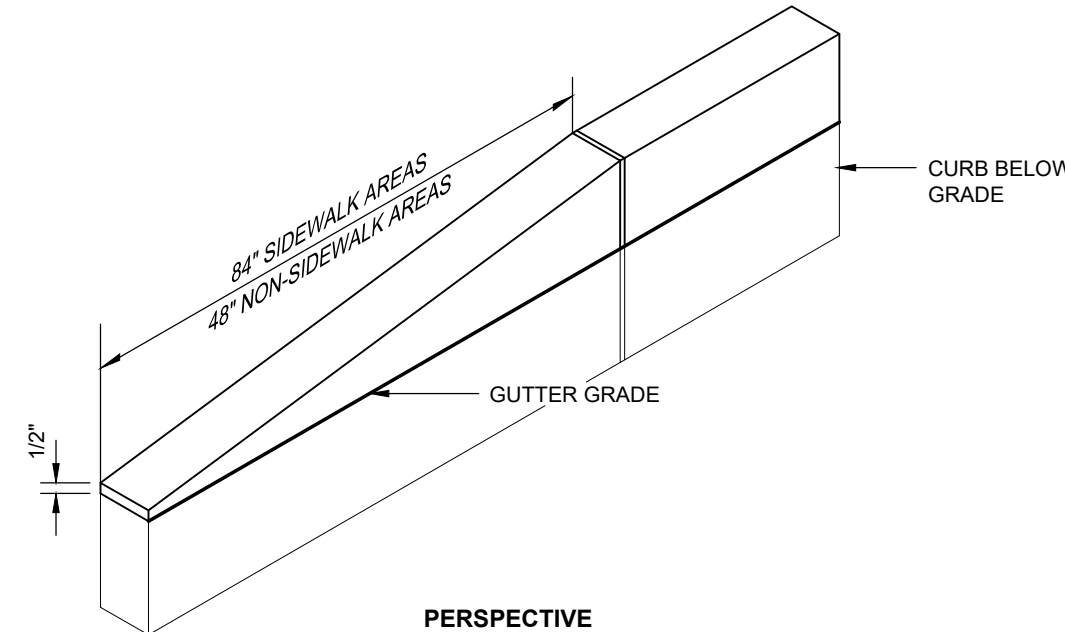

PERSPECTIVE

TYPICAL CURB TERMINATION DETAIL

N.T.S.

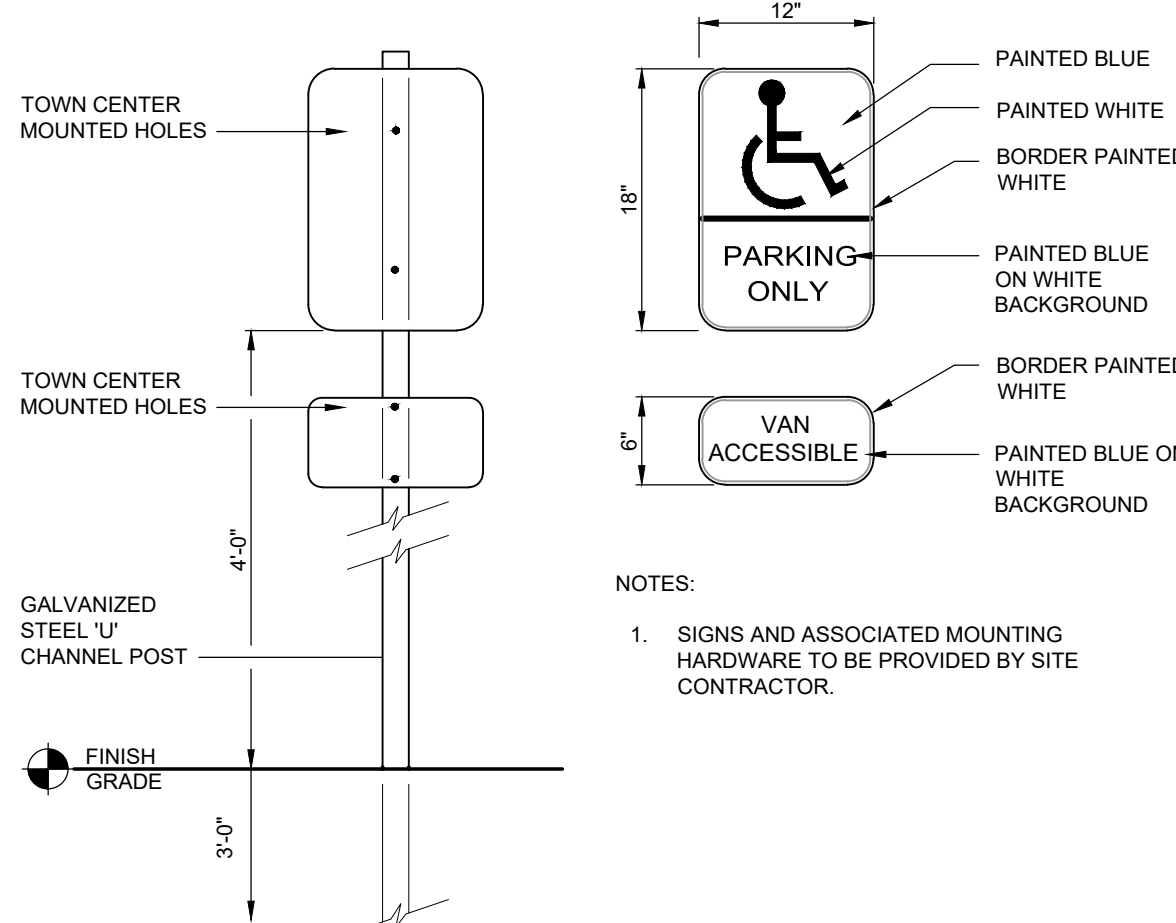


NOTES:

1. SIGNS AND ASSOCIATED MOUNTING HARDWARE TO BE PROVIDED BY SITE CONTRACTOR.

TYPICAL HANDICAP PARKING SIGN DETAIL


N.T.S.

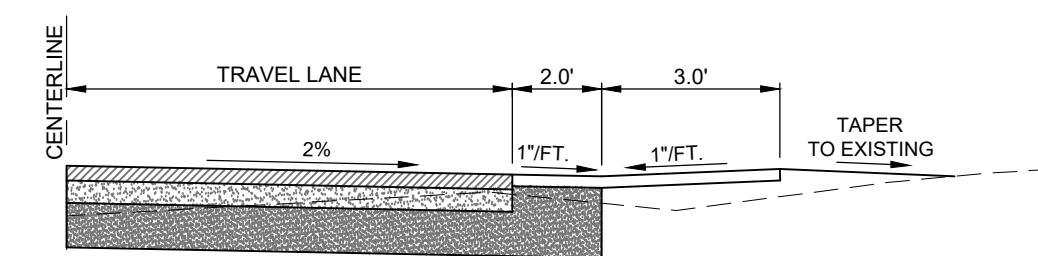

NOTE:
GUTTERS SHALL BE INSTALLED TO DIRECT STORM WATER AWAY FROM APRONS AS DIRECTED BY THE ENGINEER.

TYPICAL VALLEY GUTTER DETAIL

N.T.S.

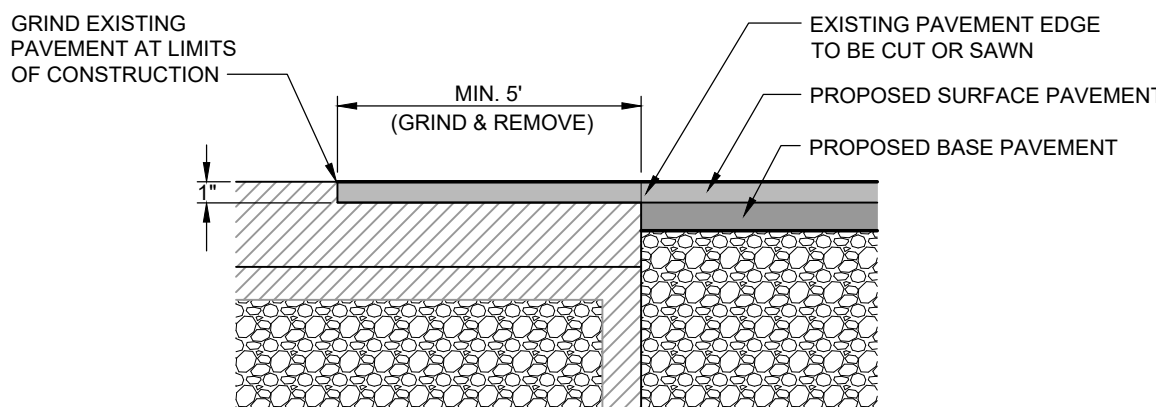


NOTES:

1. EXTEND NEW SURFACE PAVEMENT ACROSS BUTT JOINT IN BASE COURSE.
2. PROVIDE TACK COAT ON ALL SURFACES OF EXISTING PAVEMENT TO BE COVERED.

TYPICAL ASPHALT PAVEMENT GRINDING DETAIL


N.T.S.

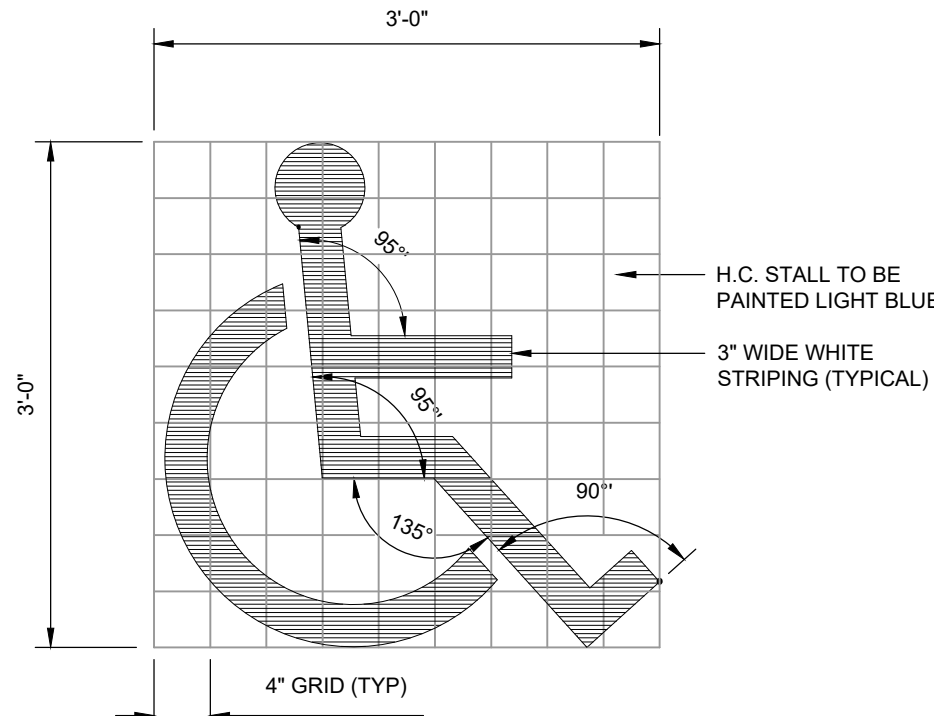

NOTE: CENTER SYMBOL WITHIN PARKING STALL

TYPICAL HANDICAP PARKING STALL SYMBOL

N.T.S.

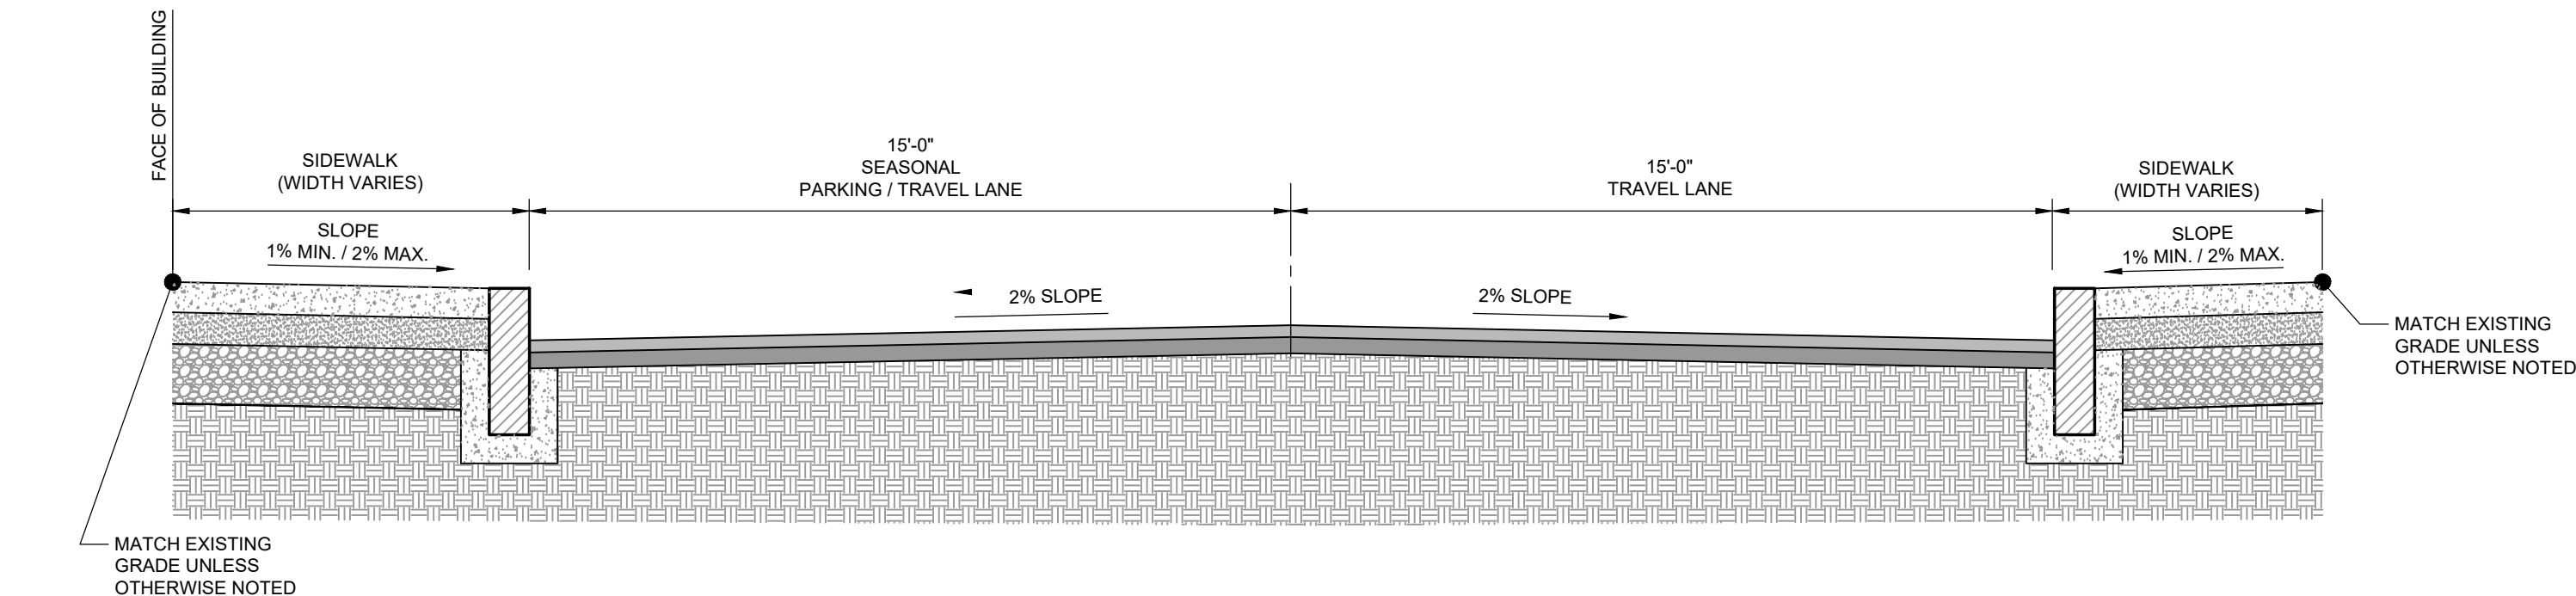

TYPICAL ROAD CROSS SECTION

N.T.S.

CES INC
Engineers • Environmental Scientists • Surveyors

PROJECT TITLE
NORTHEAST HARBOR VILLAGE CENTER IMPROVEMENTS
TOWN OF MOUNT DESERT, MAINE

PROJECT LOCATION
1000 South Main Street
PO Box 100
Bar Harbor, ME 04609
F: 207-286-6588
F: 207-286-6589
F: 207-286-6590
F: 207-286-7080
F: 207-286-

